


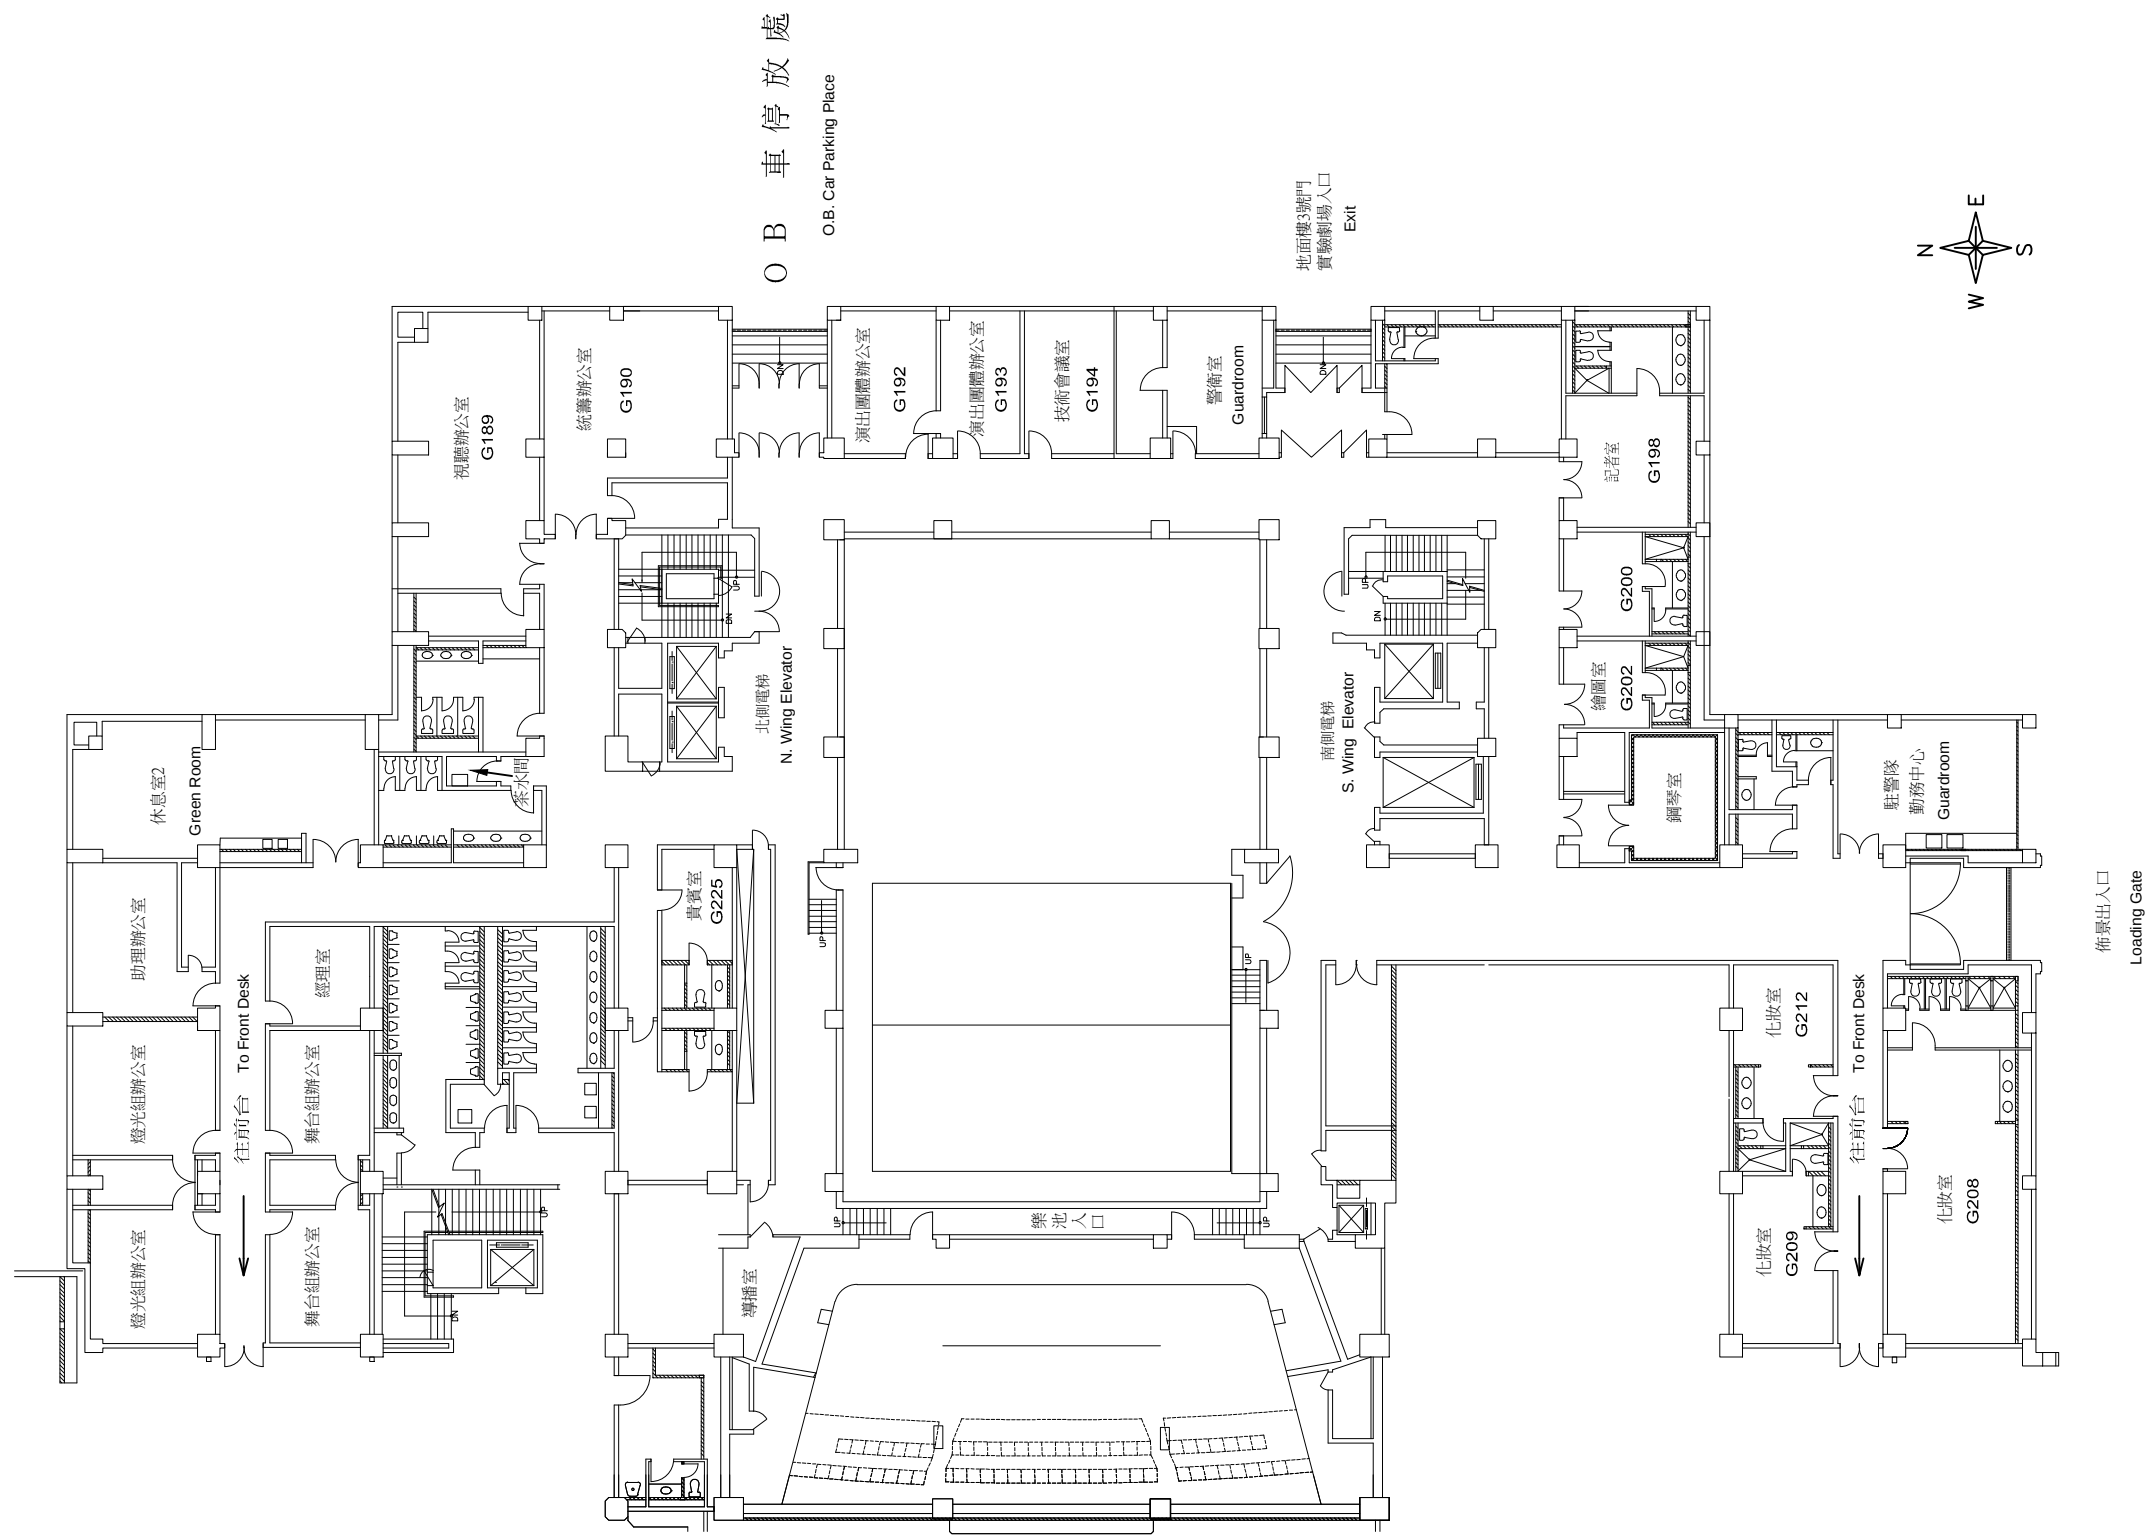

國家戲劇院

THE NATIONAL THEATER

PRODUCTION

DIRECTOR

DESIGNER

LIGHTING

SET UP

PERFORM

DRAWN BY

DATE

DRAWING TITLE

D-2 地面樓後台化粧室平面圖
D-2 Floor Plan (rear-ground dressing room)

SCALE : NO For A3

DRAWING DATE

2017 / 03

PRINT DATE